



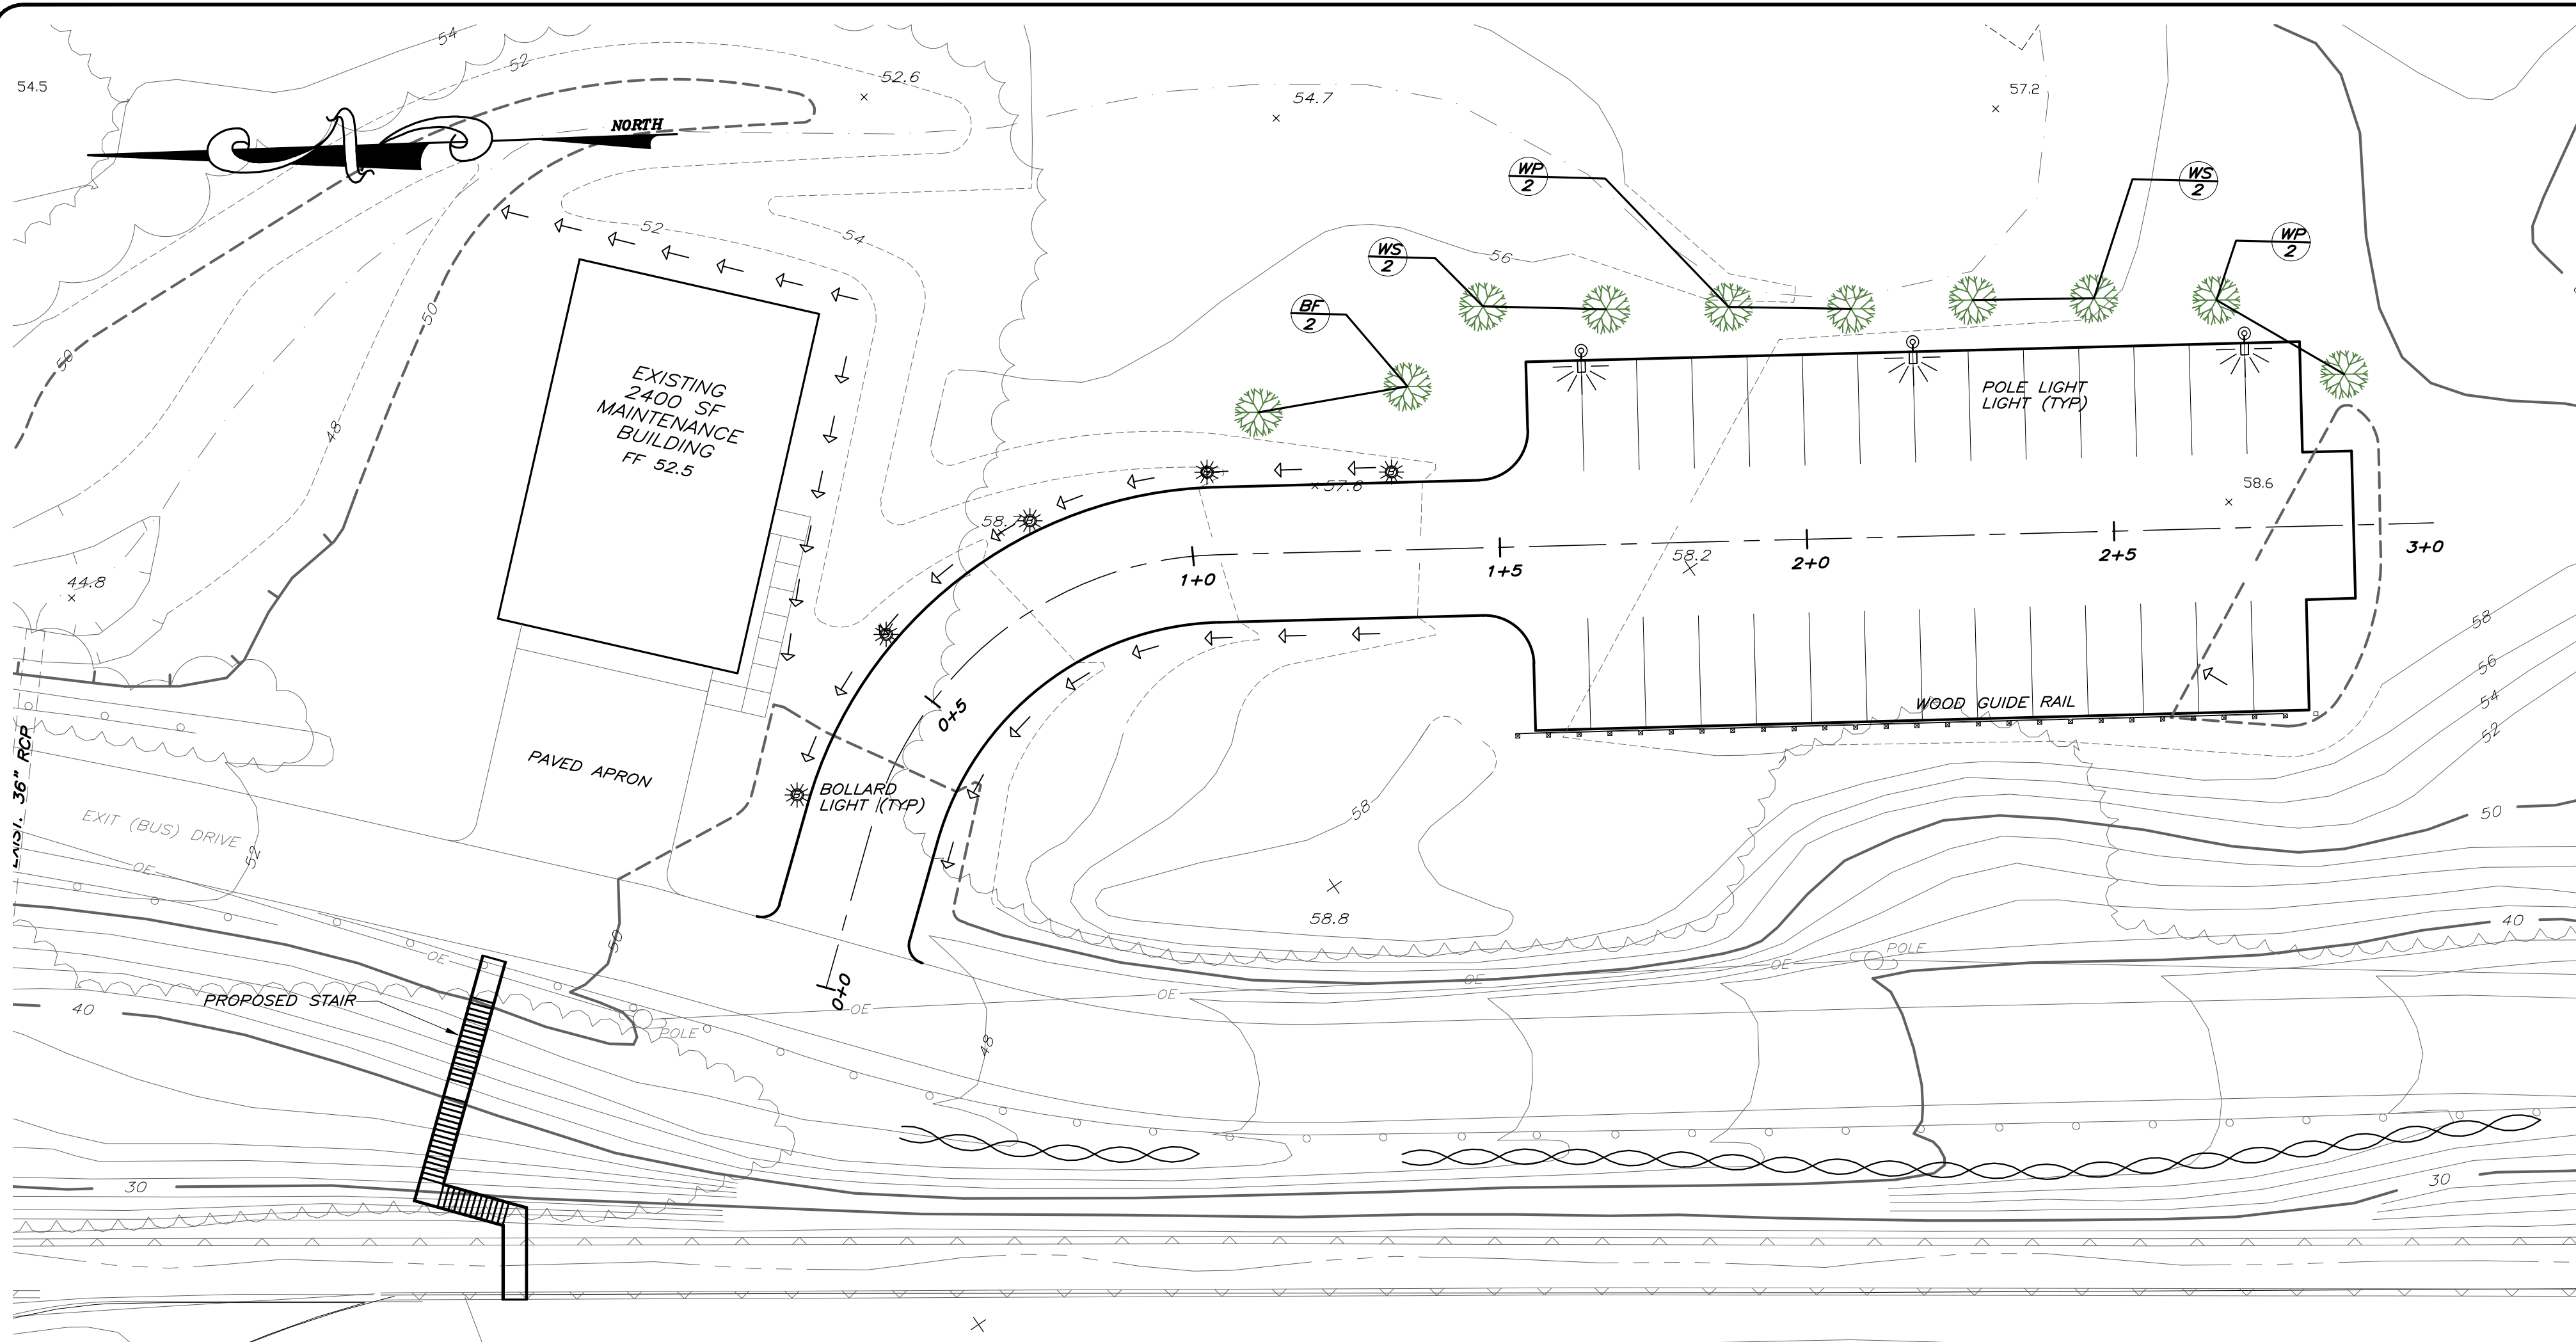

LANDSCAPE PLAN
SCALE: 1" = 20'

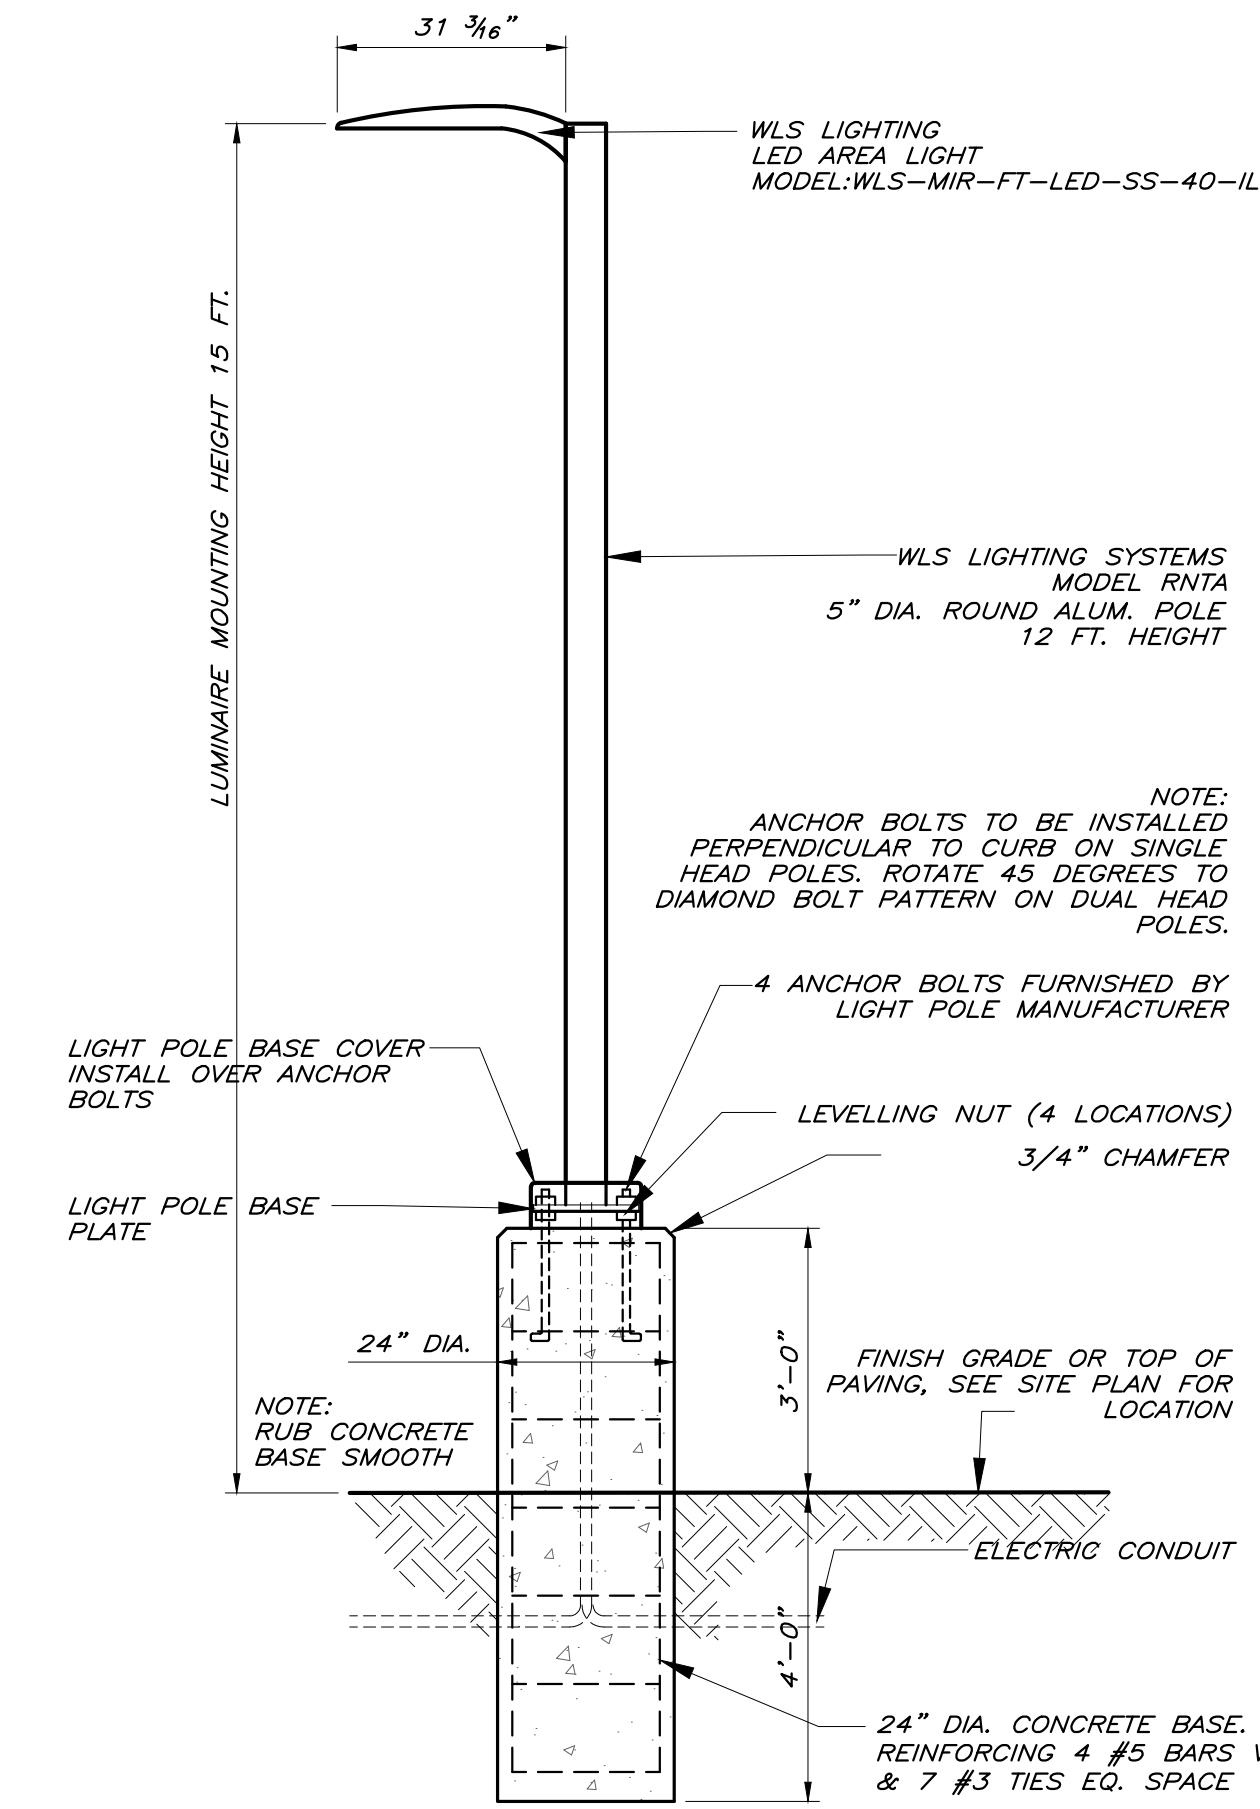

NOTE: THIS DRAWING REPRESENTS THE MINIMUM FOUNDATION REQUIREMENTS; IF MORE STRINGENT DRAWING IS SHOWN IN STRUCTURAL THEN IT SHALL GOVERN.


A
SP3

AREA LIGHT POLE

SEE SITE PLAN FOR POLE AND FIXTURE LOCATIONS AND ORIENTATIONS.

SYMBOL

SCALE: N.T.S.

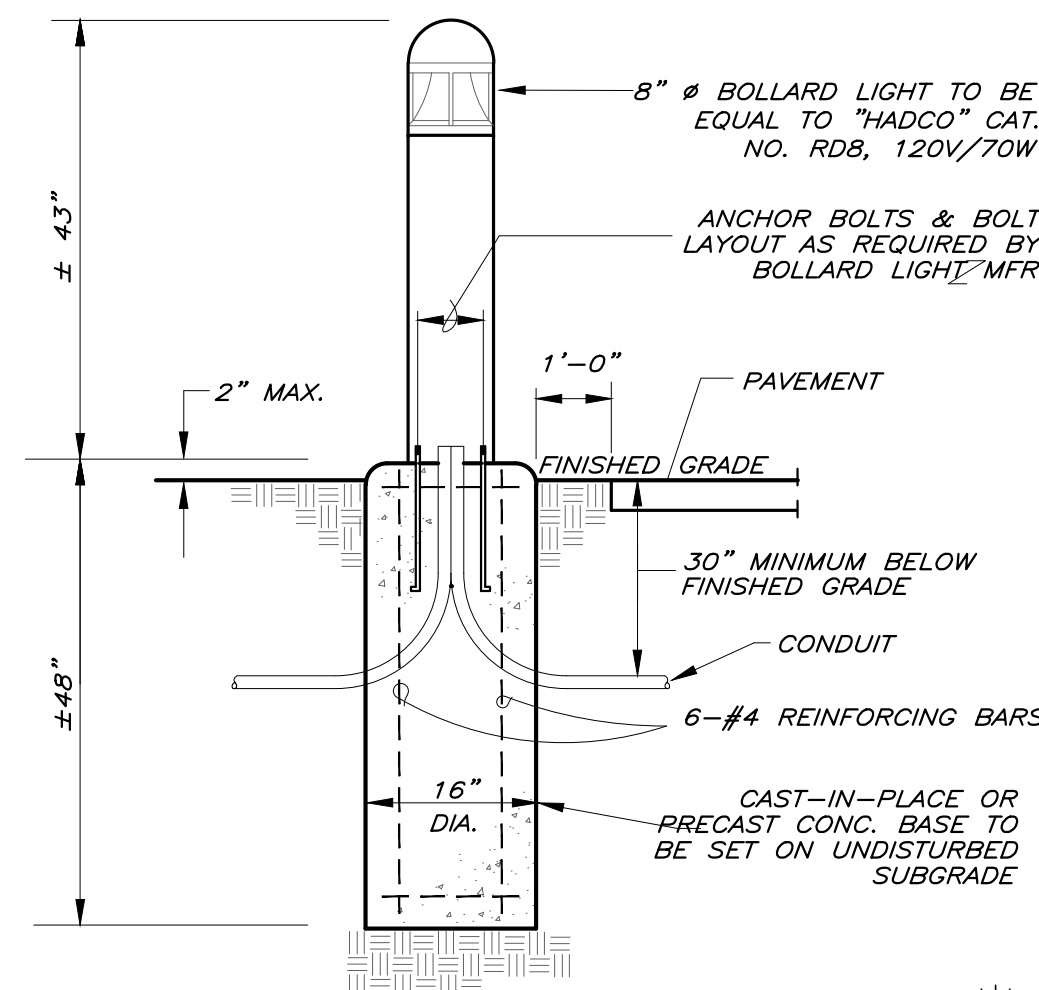


SYMBOL

B
SP3

BOLLARD LIGHT DETAIL

SEE SITE PLAN FOR POLE AND FIXTURE LOCATIONS AND ORIENTATIONS.

SCALE: N.T.S.

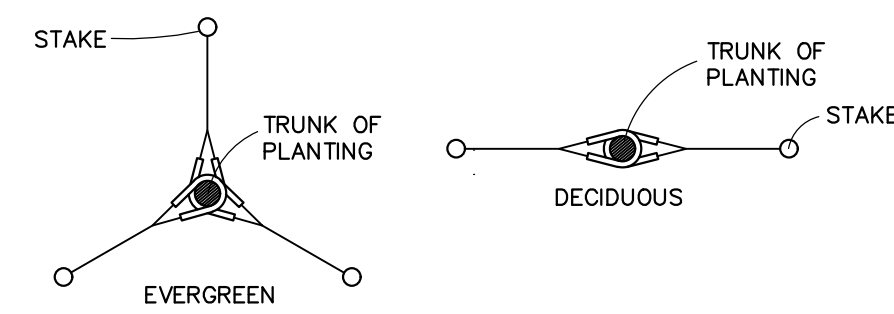


STAKE PLACEMENT

EVERGREEN TREE

PLANTING REFERENCE
QUANTITY

PLANTING KEY

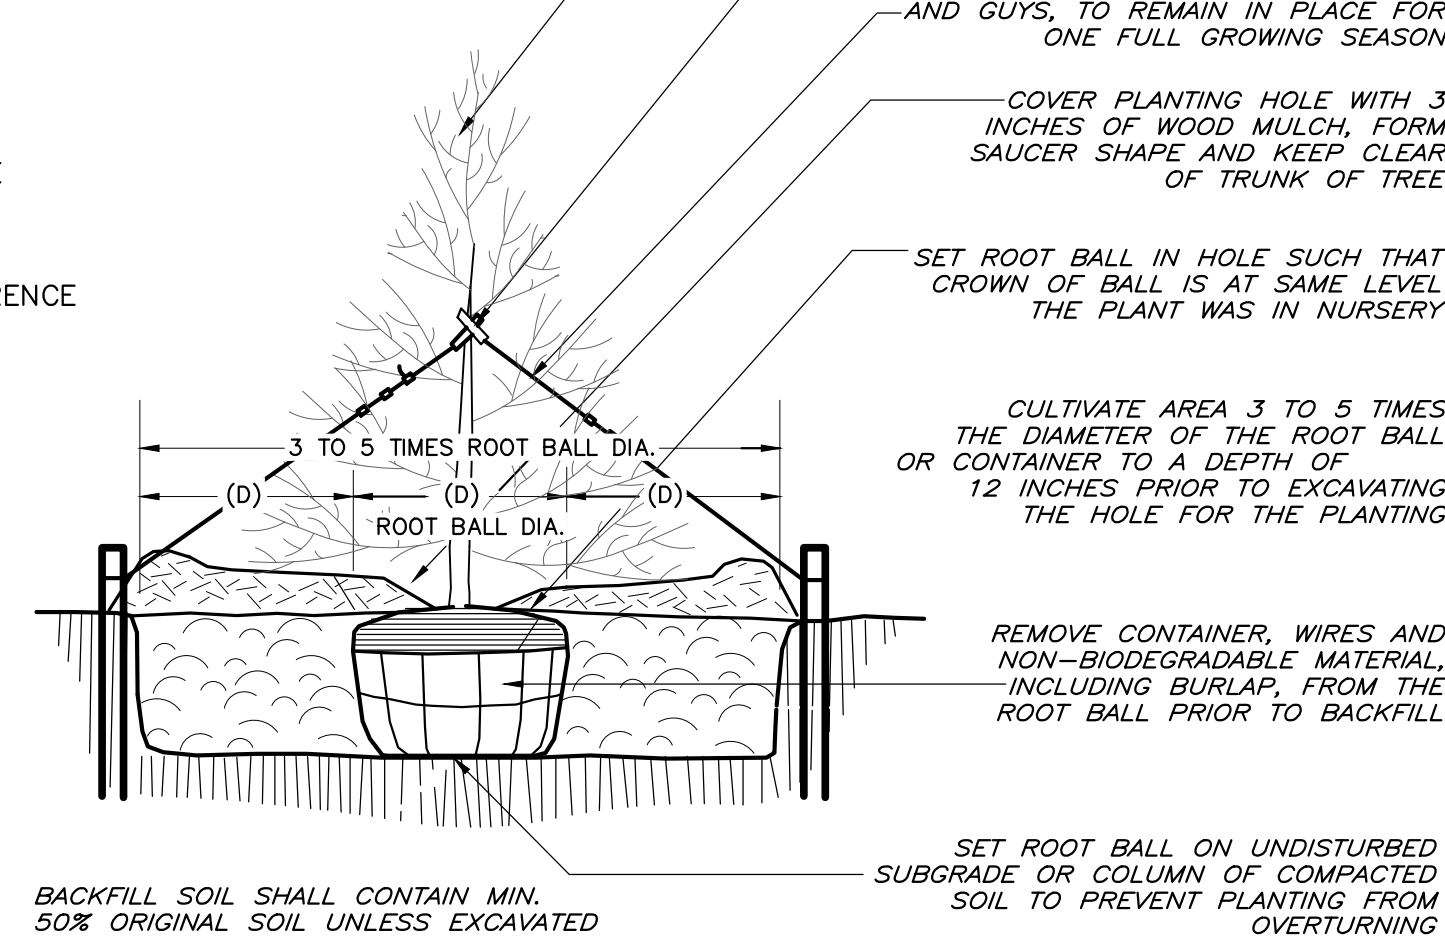

TREE PLANTING DETAIL

SCALE: NONE

PLANTING SCHEDULE


SYMBOL	QTY.	COMMON NAME	BOTANICAL NAME	SIZE/CALIPER	REMARKS
BF	2	BALSAM FIR	ABIES BALSAMEA	6' TO 7' HEIGHT.	BALLED & BURLAP (B & B)
WP	4	WHITE PINE	PINUS STROBUS	7' TO 8' HEIGHT	(B & B)
WS	4	WHITE SPRUCE	PICEA GLAUCA	7' TO 8' HEIGHT	(B & B)




THIS DRAWING IS ONE IN A SET OF DRAWINGS & IS INCOMPLETE & INVALID WHEN IT IS SEPARATED FROM THIS SET.
Unauthorized alteration or addition to this drawing is a violation of Section 7209 (2) of the NYS Education Law.

NO.	DATE	DESCRIPTION	BY

T. M. DEPUY
ENGINEERING & LAND SURVEYING, P.C.
2656 ROUTE 302, MIDDLETOWN, NY 10941
PHONE: (845) 361-5421 FAX: (845) 361-5229

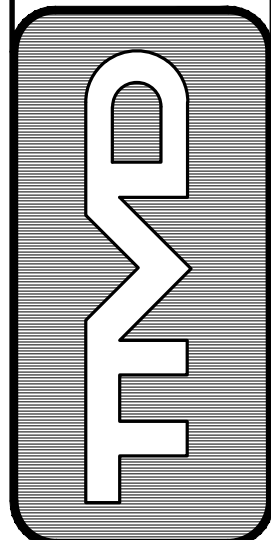

PROPOSED EMPLOYEE PARKING LOT
DIA CENTER FOR THE ARTS
CITY OF BEACON
DUTCHESS COUNTY, NEW YORK

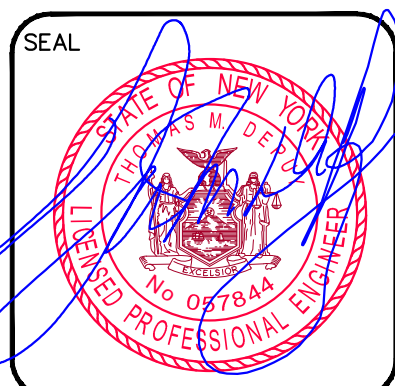

TITLE
LANDSCAPE
AND SITE
LIGHTING
PLAN

JOB 99021.PL
DATE JAN. 28, 2019
SCALE 1" = 20"
DWG.

SP3
OF 4