



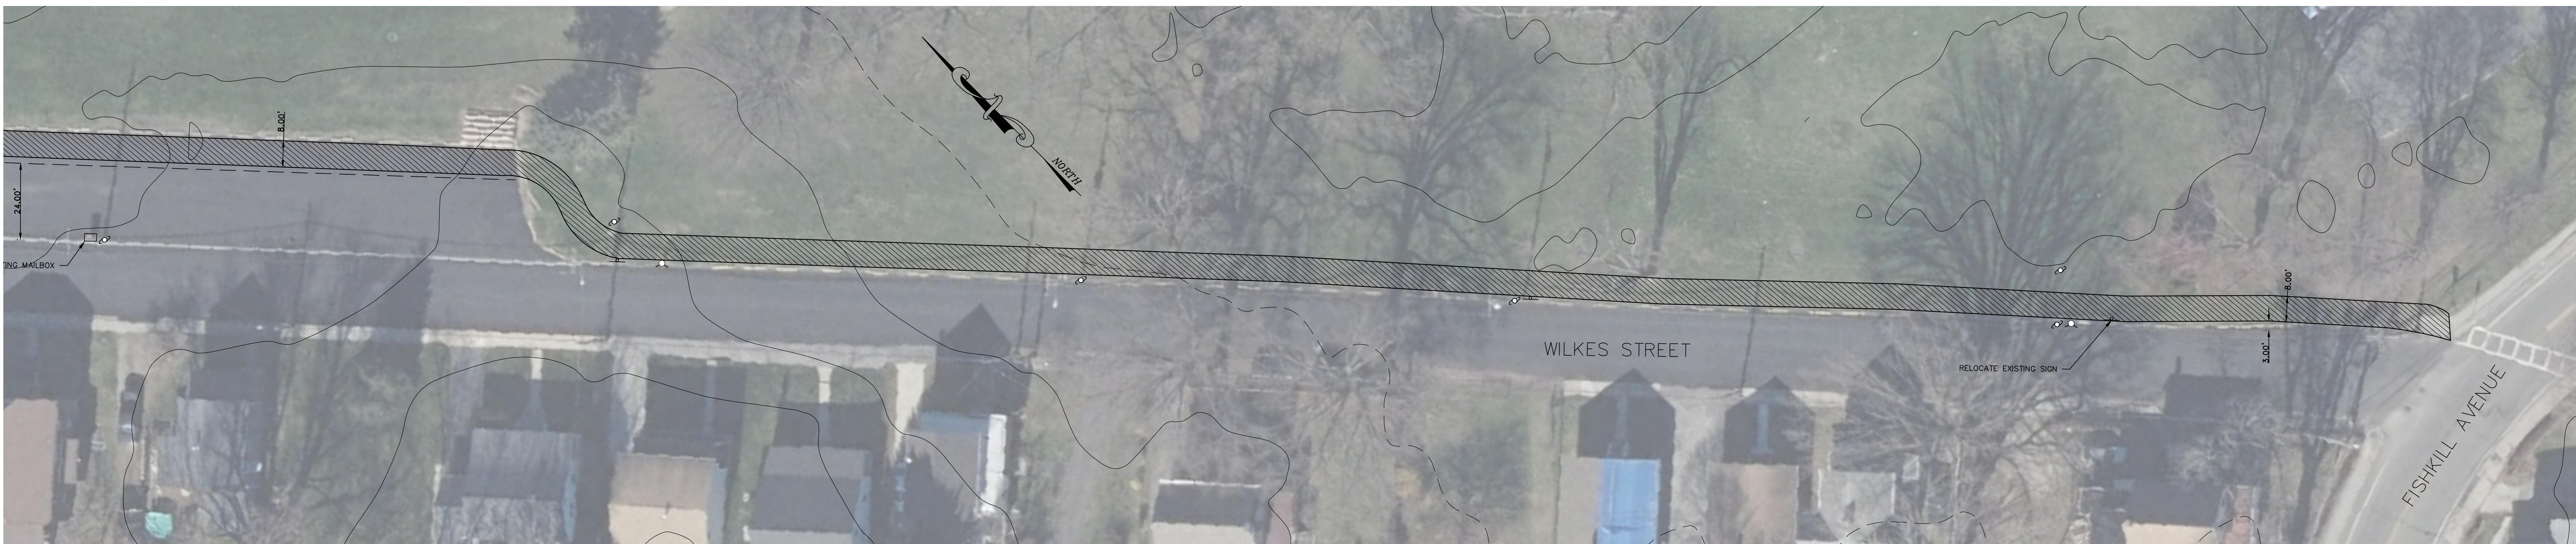


LOCATION PLAN
1 INCH = 2000 FEET

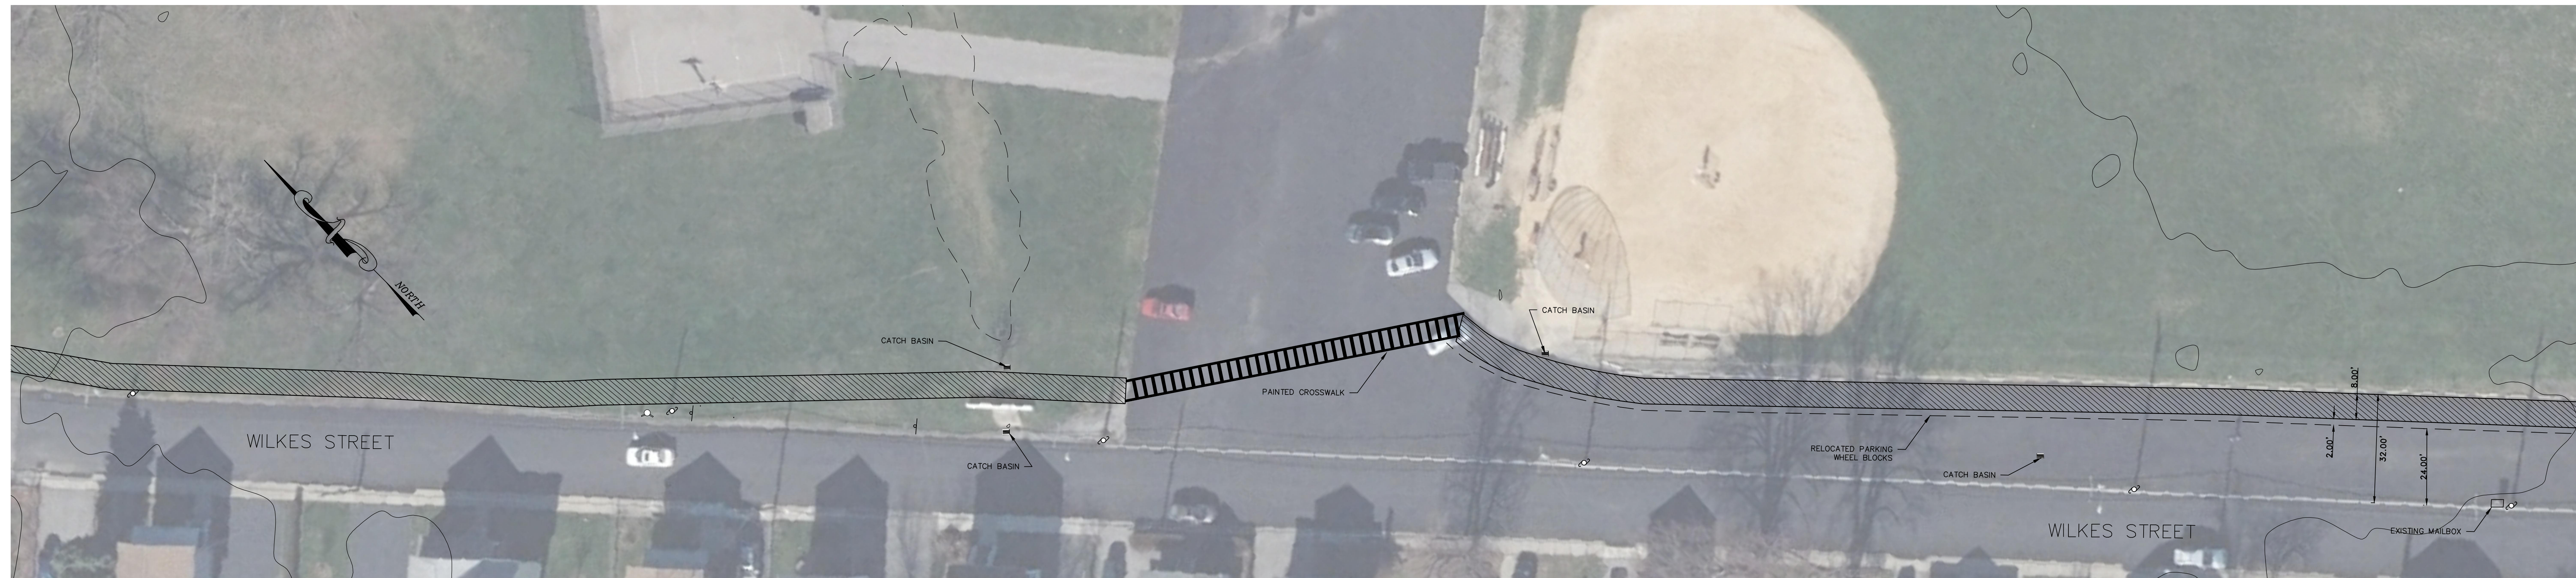


COPYRIGHT 2019, LANC & TULLY, P.C.

LEGEND

- EXISTING FIRE HYDRANT
- EXISTING SIGN
- EXISTING UTILITY POLE
- PROPOSED WALKWAY

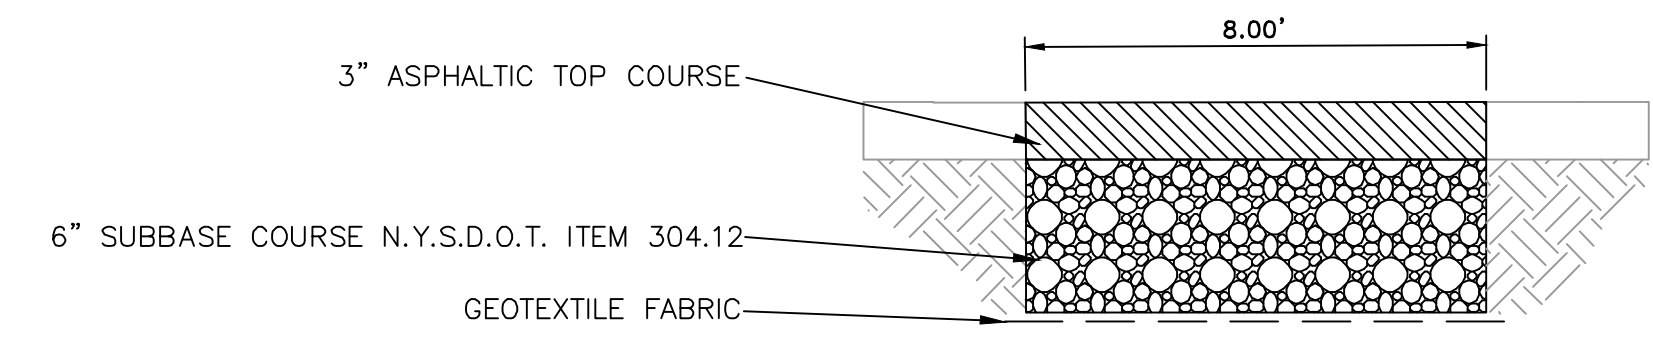

WALKWAY DETAIL
NOT TO SCALE

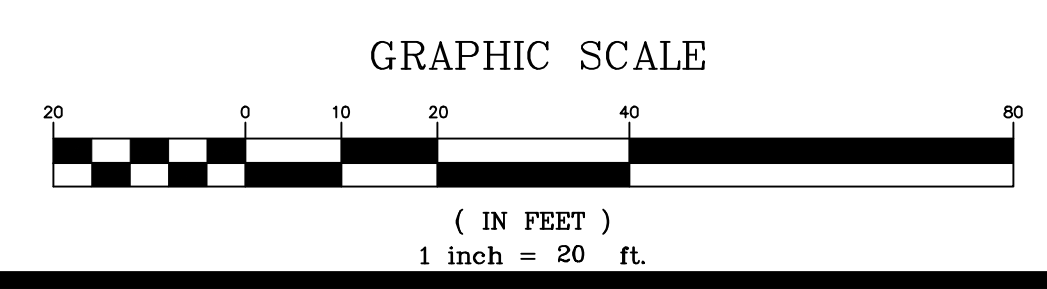

COPIES FROM THE ORIGINAL OF THIS DOCUMENT NOT MARKED WITH AN ORIGINAL OF THE PROFESSIONAL ENGINEER'S AND/OR LAND SURVEYOR'S STAMP OR EMBOSSED SEAL SHALL NOT BE CONSIDERED VALID, TRUE COPIES.

UNAUTHORIZED ALTERATION OR ADDITION TO THIS DOCUMENT IS A VIOLATION OF SECTION 7209-2 OF THE NEW YORK STATE EDUCATION LAW.



LANC & TULLY ENGINEERING AND SURVEYING, P.C.		P.O. Box 687, Rt. 207 Goshen, N.Y. 10924 (845) 294-3700	
WALKWAY PLAN PREPARED FOR			
WILKES STREET WALKWAY			
CITY OF BEACON DUTCHESS COUNTY, NEW YORK			
Drawn By: CB	Checked By:	Scale: 1" = 20'	Tax Map No.: N/A
Date: SEPTEMBER 13, 2019		Revision:	
CAD File: 190903-SITEPLAN1.DWG		Drawing No.: C30	
Layout: SITE PLAN		Sheet No.: 1 OF 1	
A - 19 - 5855 - 01		19	