

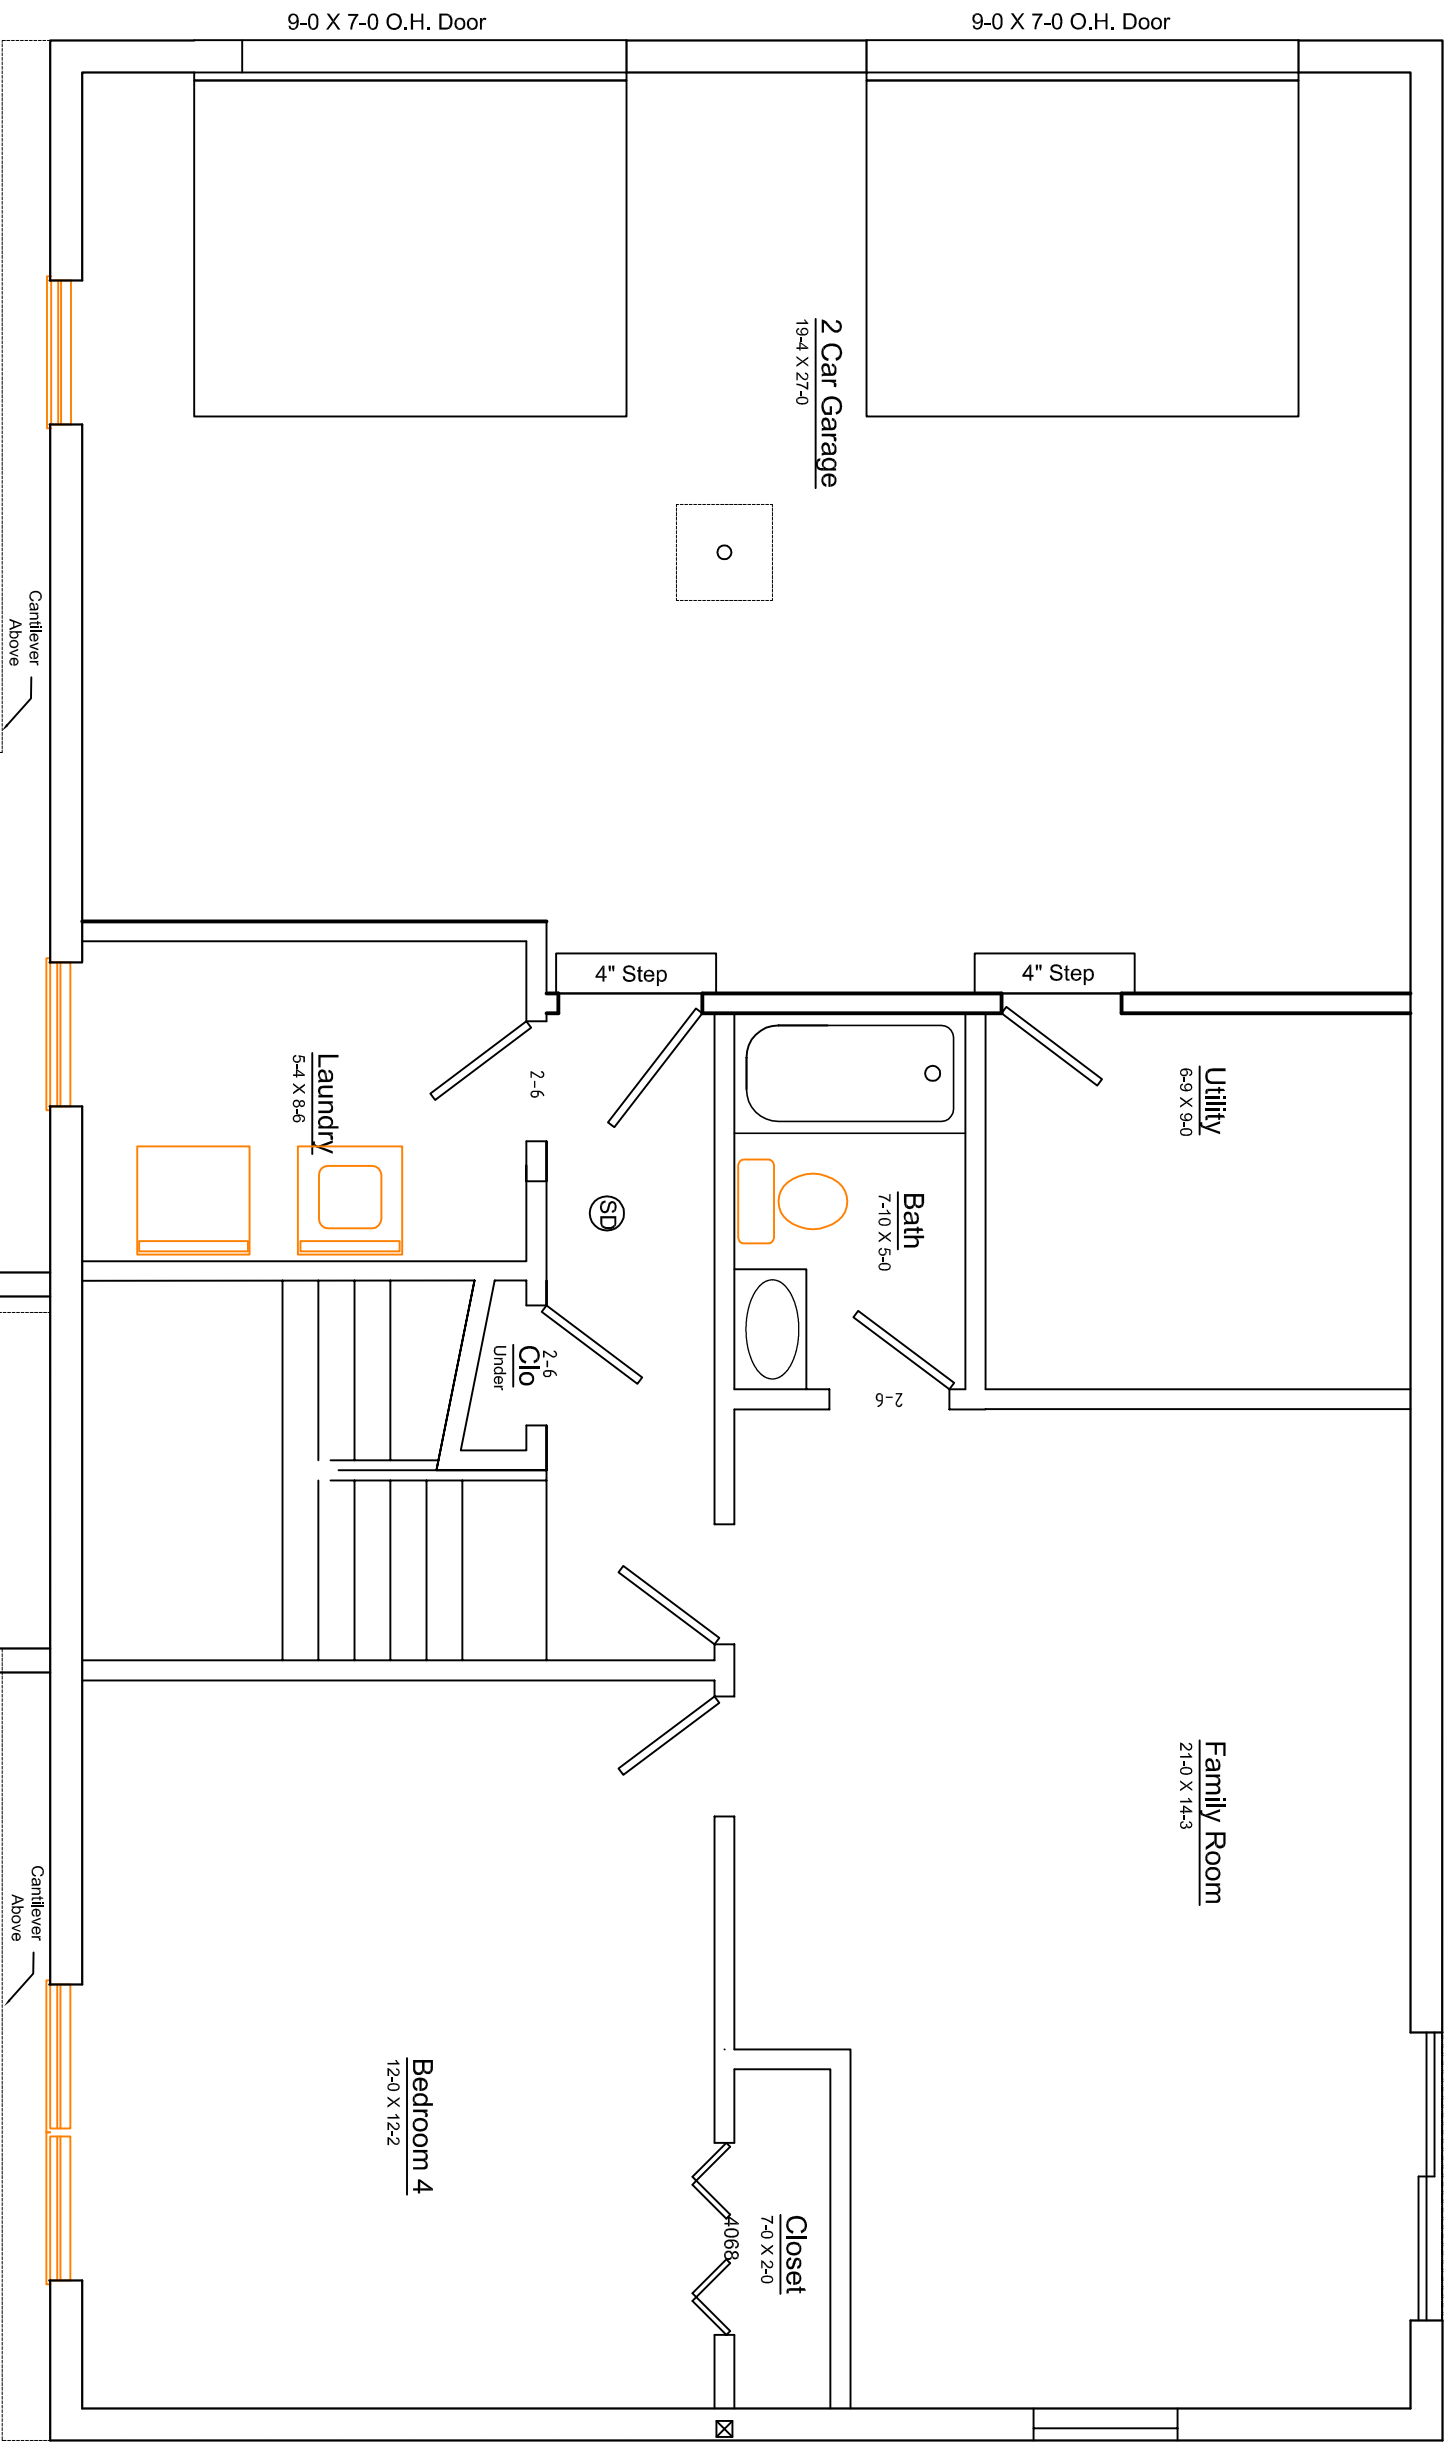


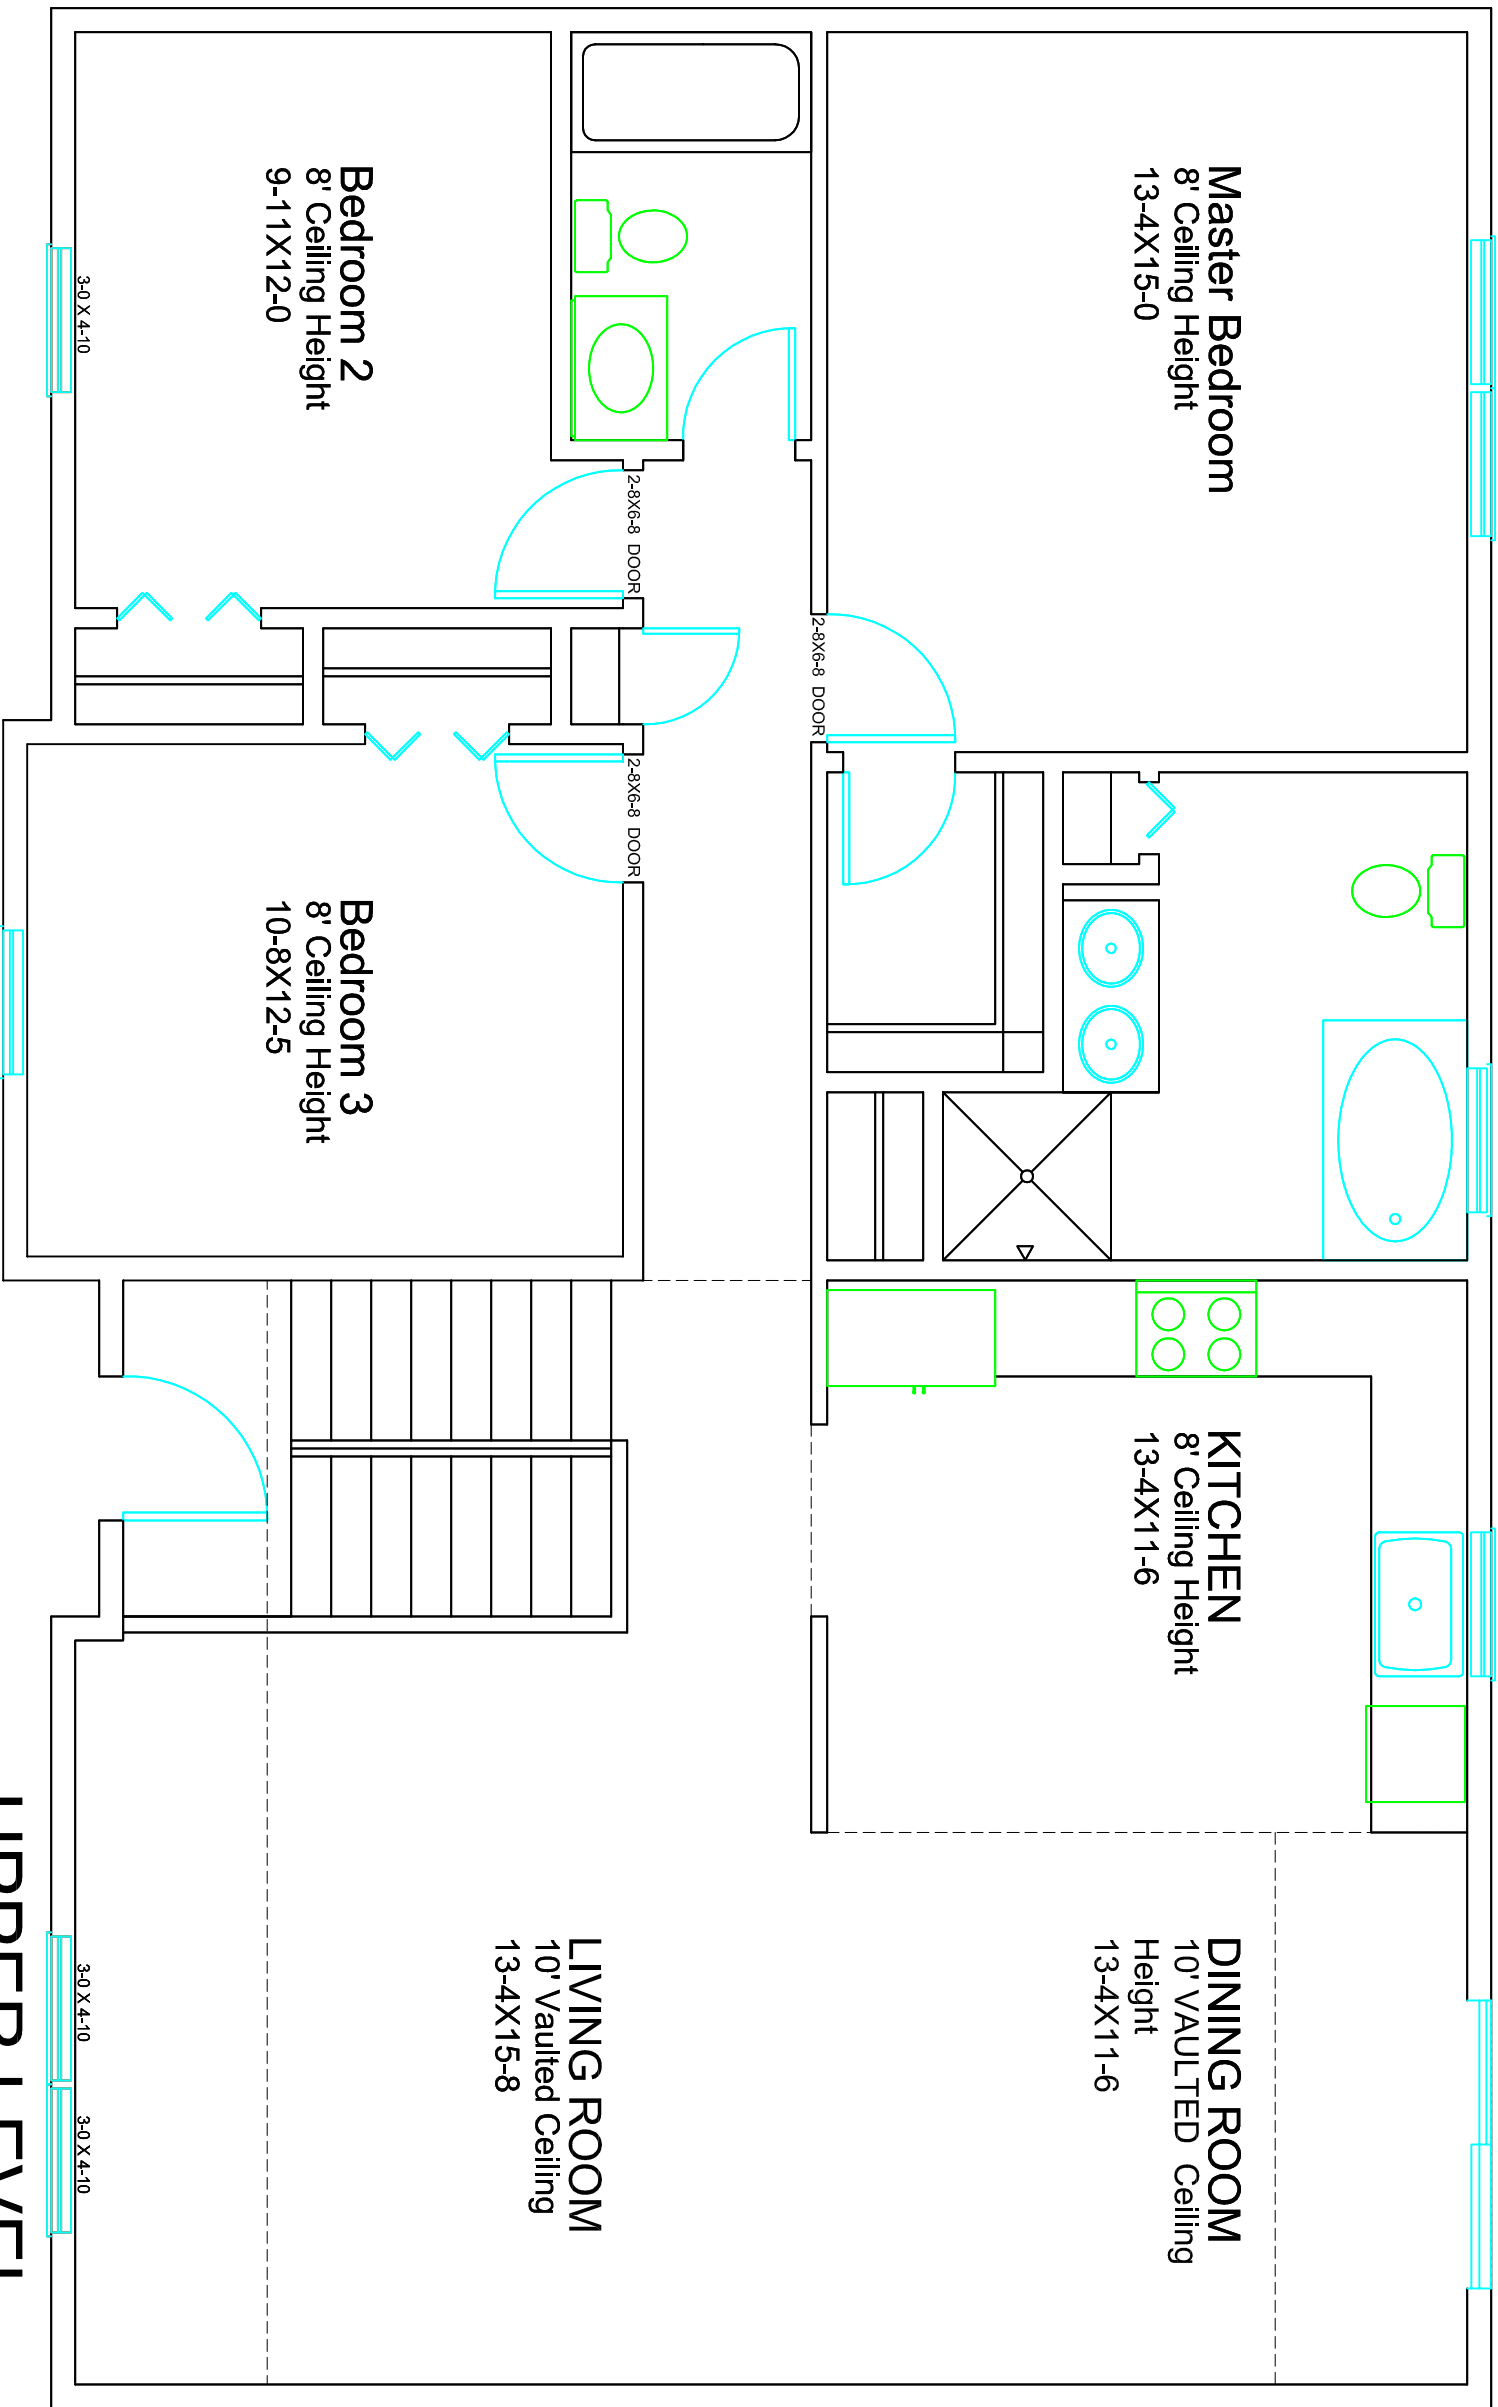


GROUND FLOOR

Scale: 1/4" = 1'

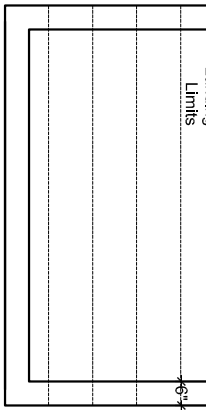

UPPER LEVEL

Scale: 1/4" = 1'

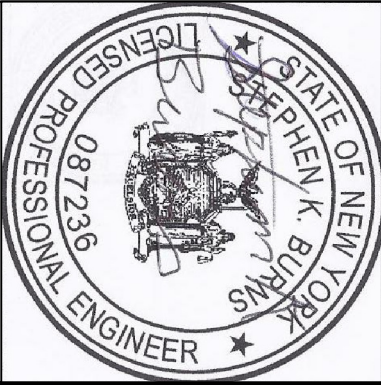

The plans and specifications herein are intended for the subject project ONLY as a result of Contractual Negotiations between the builders, the client noted and Burns Engineering Services, P.C.. These plans and specifications will be the subject of a copyright petition and may not be revised or reused by anyone without the written authority of Burns Engineering Services, P.C..

House Plans
For
BEACON RESIDENTIAL LLC, LOT 1
"SUBDIVISION PLAN 65 DENNINGS AVE"
FM# 9679B
DENNINGS AVENUE, CITY OF BEACON
DUTCHESS COUNTY, NEW YORK
Tax ID # 5954-50-623570

Sheet Title


FLOOR PLANS

MARCH 7, 2017

Sheet

2

2

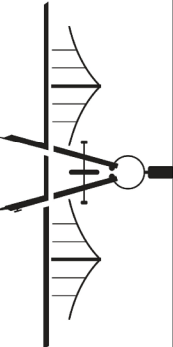

BURNS
ENGINEERING SERVICES, P.C.

Burns Engineering Services, P.C.
8415 Route 125
Beacon, NY 12508
SBurns@BurnsEngineeringServices.Com
Fax (845) 440-7343