


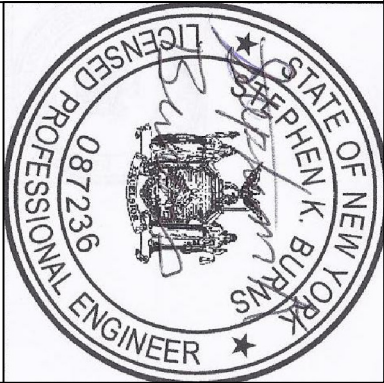

The plans and specifications herein are intended for the subject project ONLY as a result of Contractual Negotiations between the builders, the client noted and Burns Engineering Services, P.C.. These plans and specifications will be the subject of a copyright petition and may not be revised or reused by anyone without the written authority of Burns Engineering Services, P.C..

House Plans
For
BEACON RESIDENTIAL LLC, LOT 2
"SUBDIVISION PLAN 65 DENNINGS AVE"
FM# 9679B
DENNINGS AVENUE, CITY OF BEACON
DUTCHESS COUNTY, NEW YORK
Tax ID # 5954-50-631575

Sheet Title


FLOOR PLANS

MAY 17, 2017

Sheet

2


2

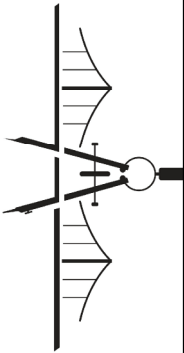

ENGINEERING SERVICES, P.C.


BURNS

Burns Engineering Services, P.C.
58 Teller Avenue
Beacon, NY 12508
SBurns@BurnsEngineeringServices.Com
(845) 546-3310
Fax (845) 440-7343

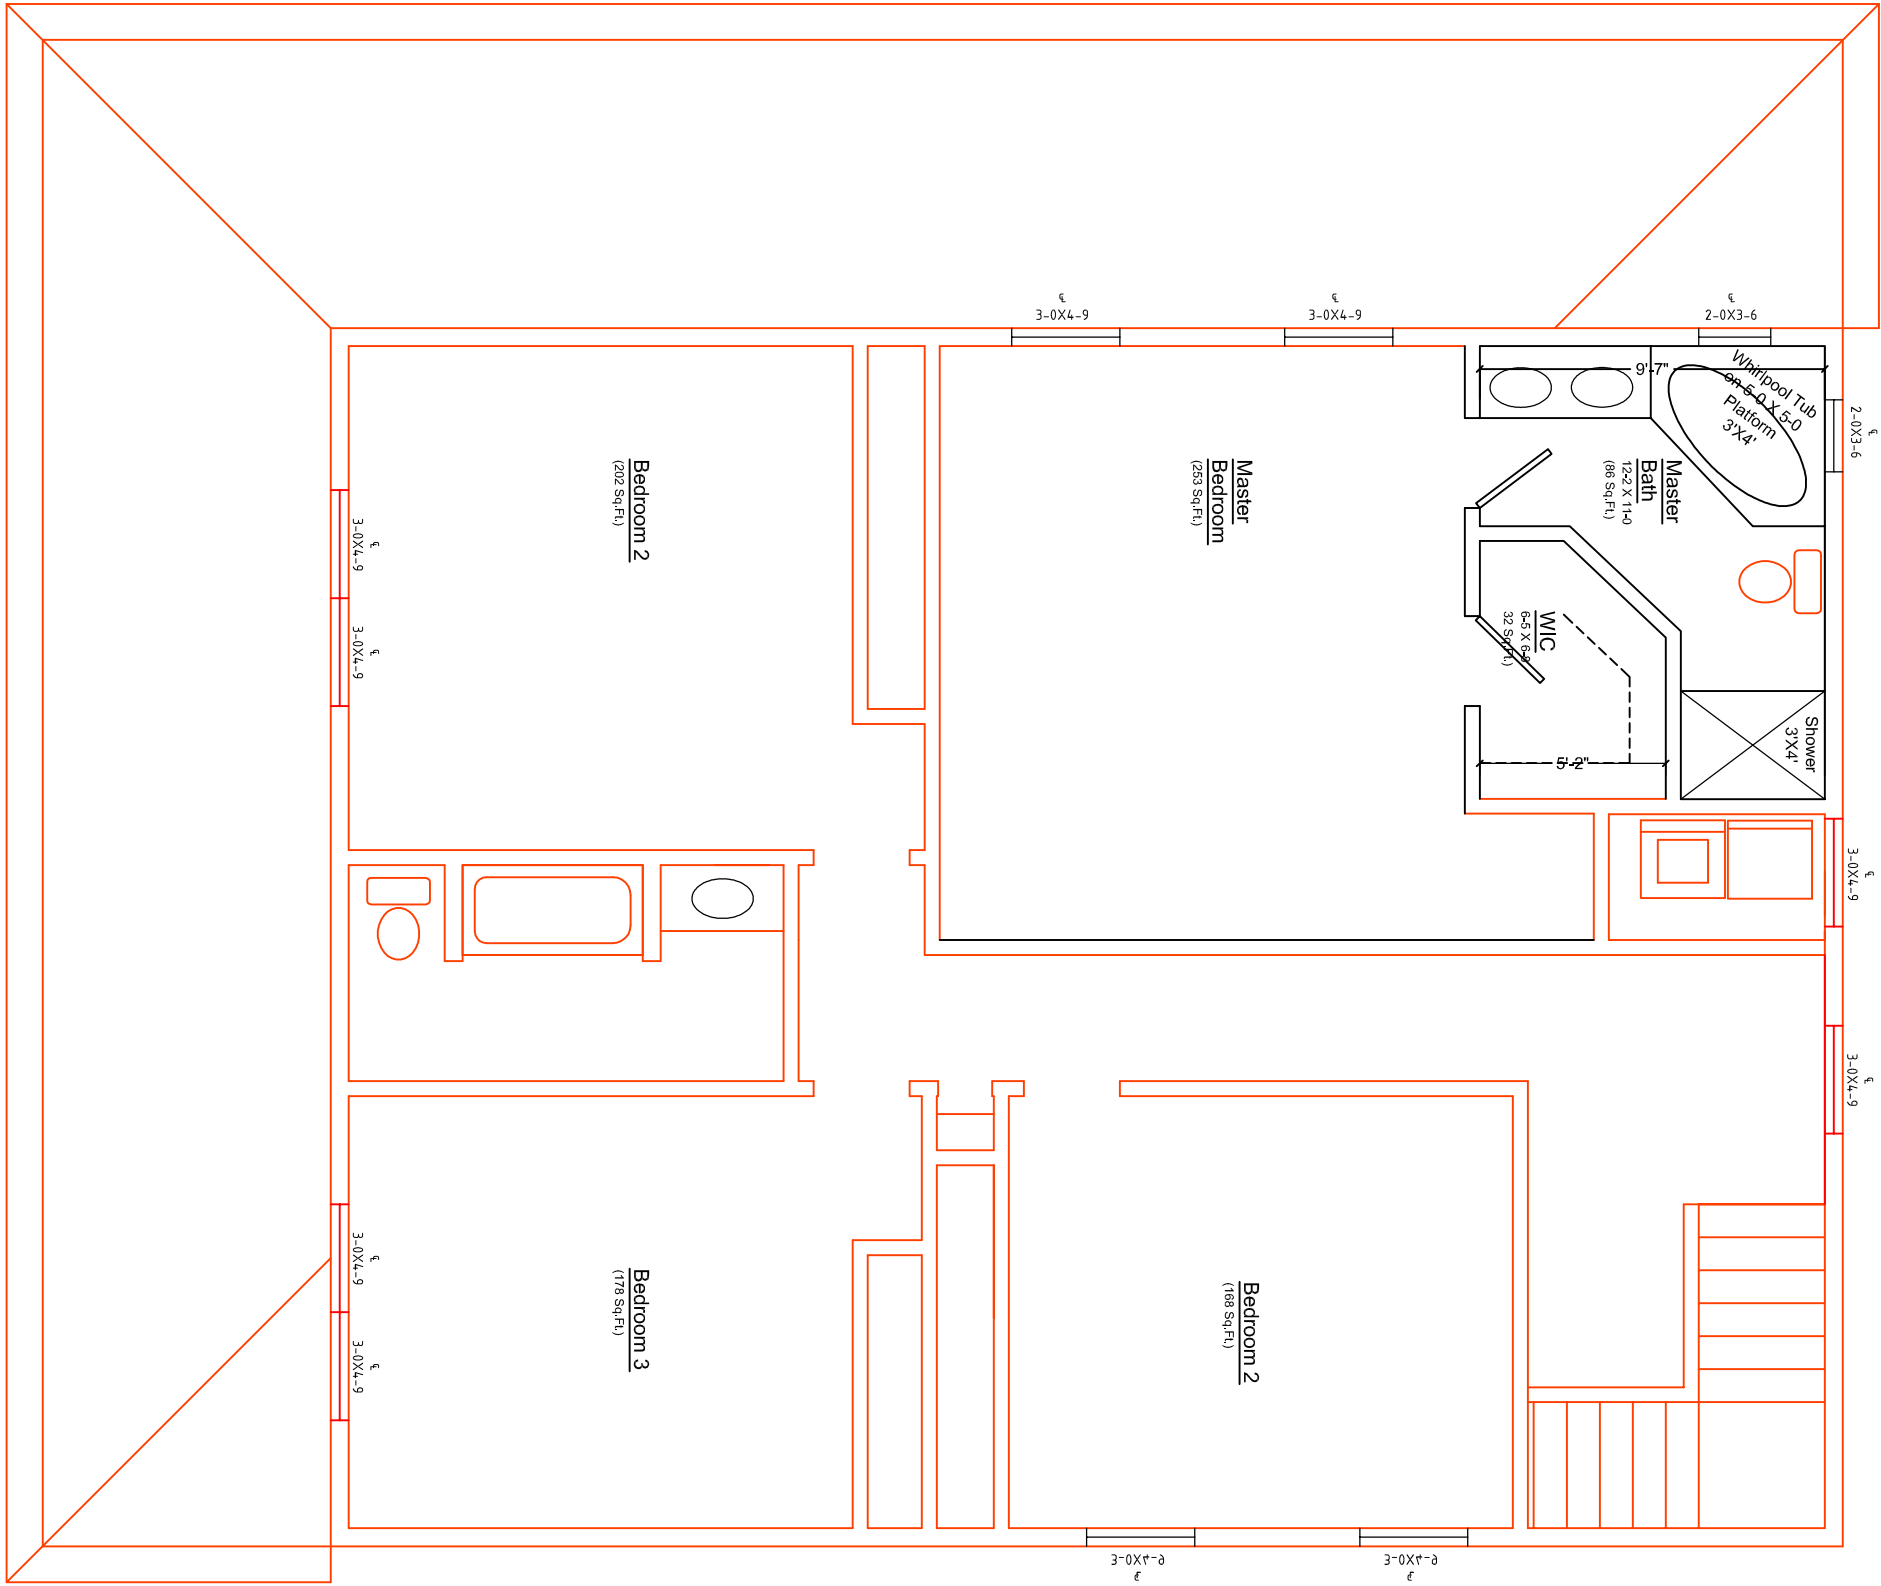

1 Upper Level Floor Plan

SCALE: 3/8" = 1'-0"

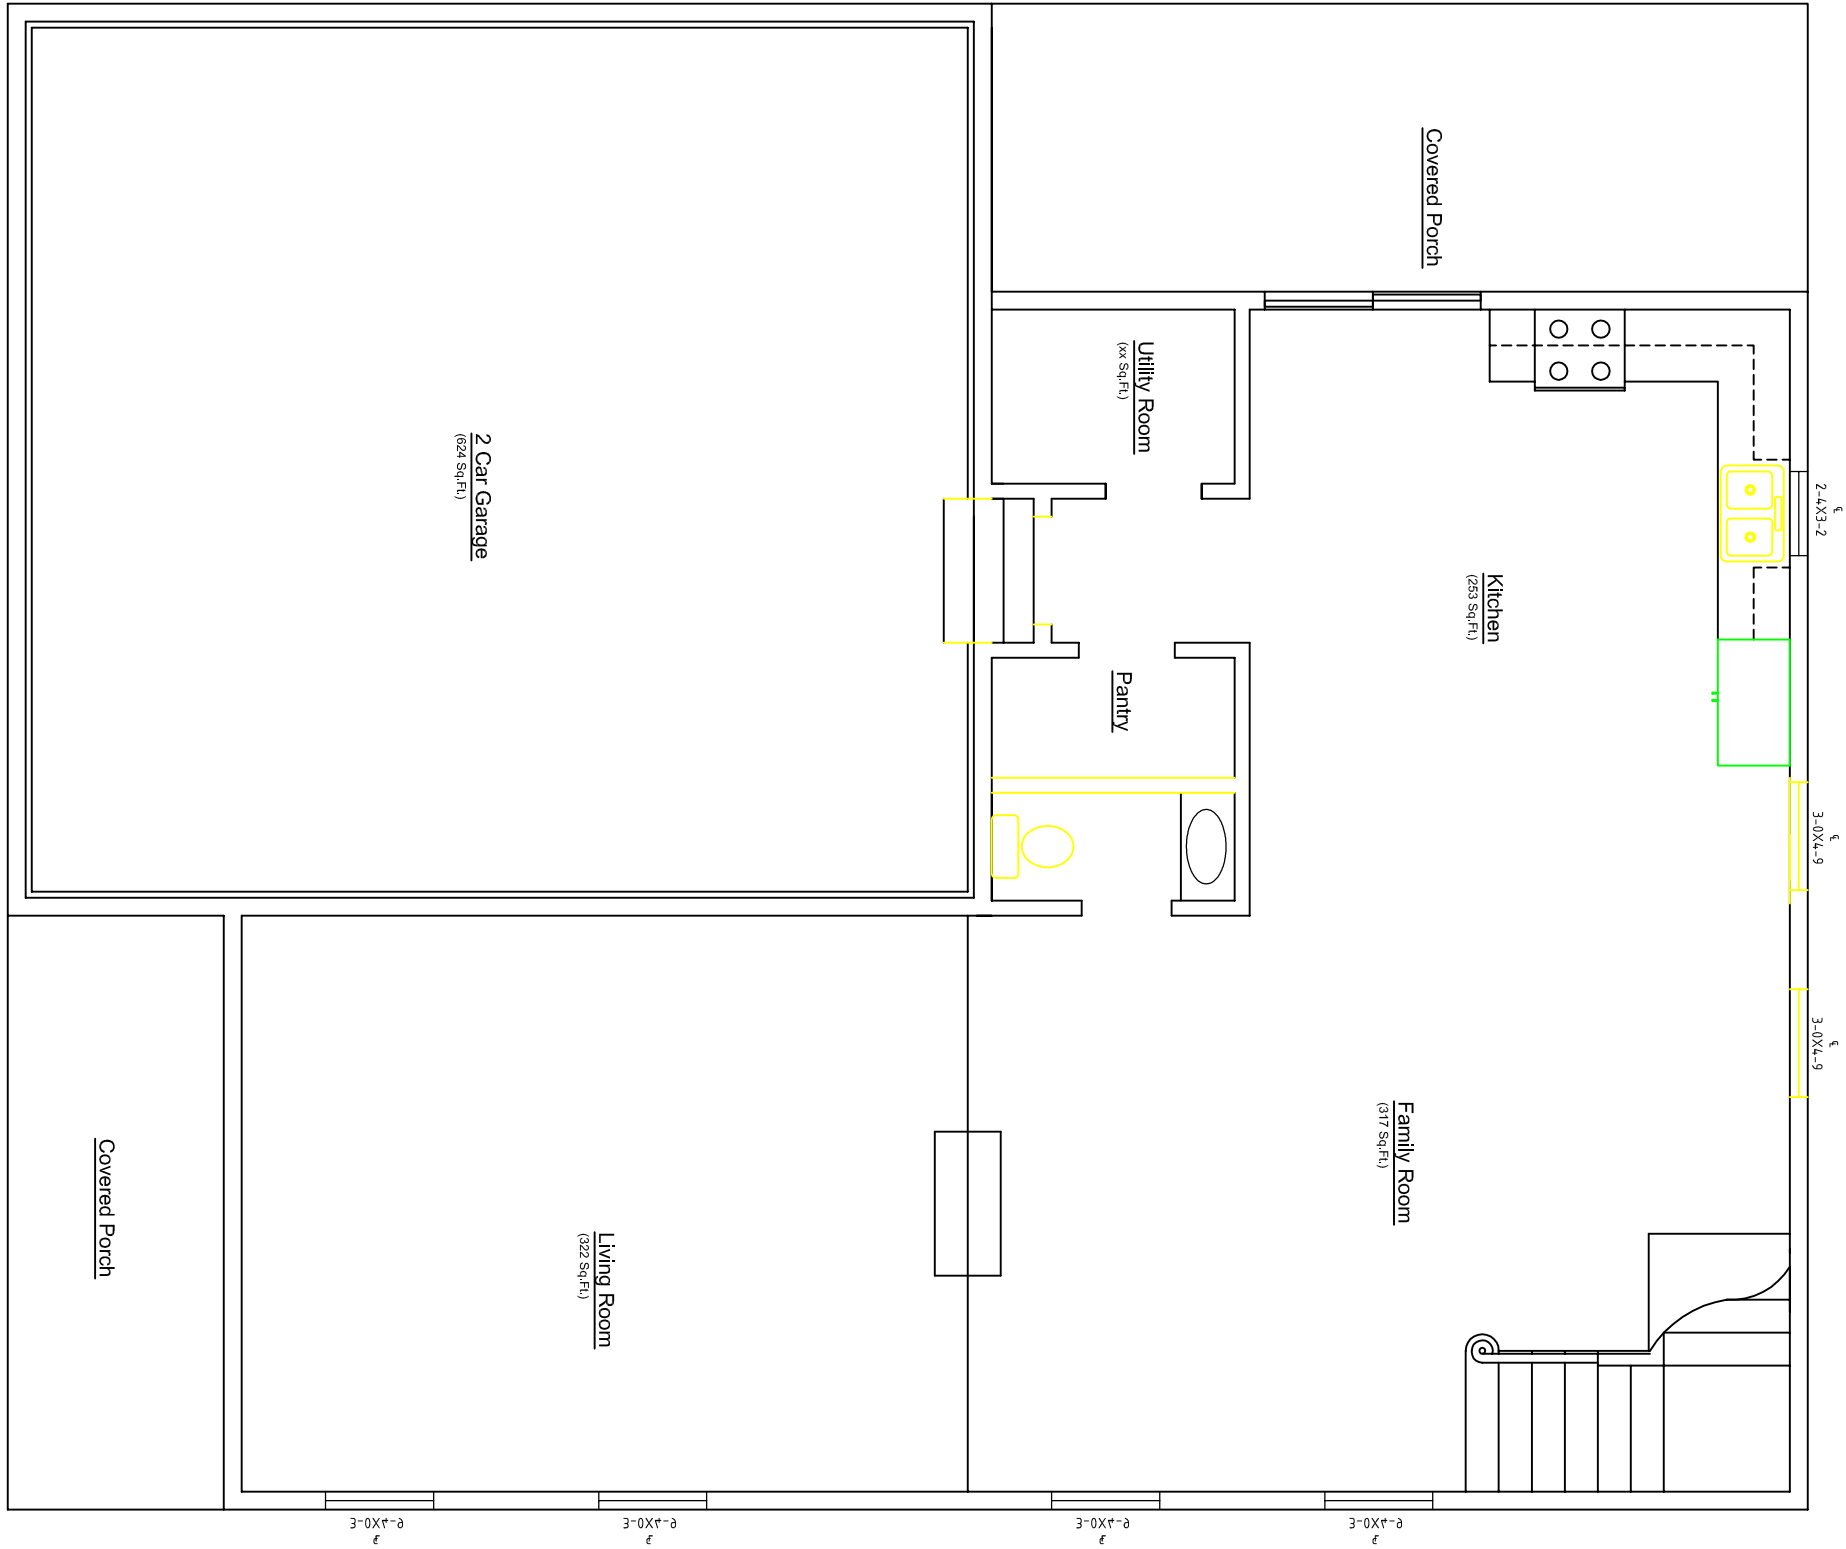

1 Lower Level Floor Plan

SCALE: 3/8" = 1'-0"