

The plans and specifications herein are intended for the subject project ONLY as a result of Contractual Negotiations between the builders, the client noted and Burns Engineering Services, P.C.. These plans and specifications will be the subject of a copyright petition and may not be revised or reused by anyone without the written authority of Burns Engineering Services, P.C..


House Plans
 BEACON RESIDENTIAL LLC, LOT1
 "SUBDIVISION PLAN 65 DENNING'S AVENUE"
 CITY OF BEACON
 DUTCHESS COUNTY, NEW YORK
 Tax ID #5954-50-623570

Sheet Title
 FLOOR PLANS


MARCH 24, 2017
 OCTOBER 31, 2017

Sheet

2 / 2

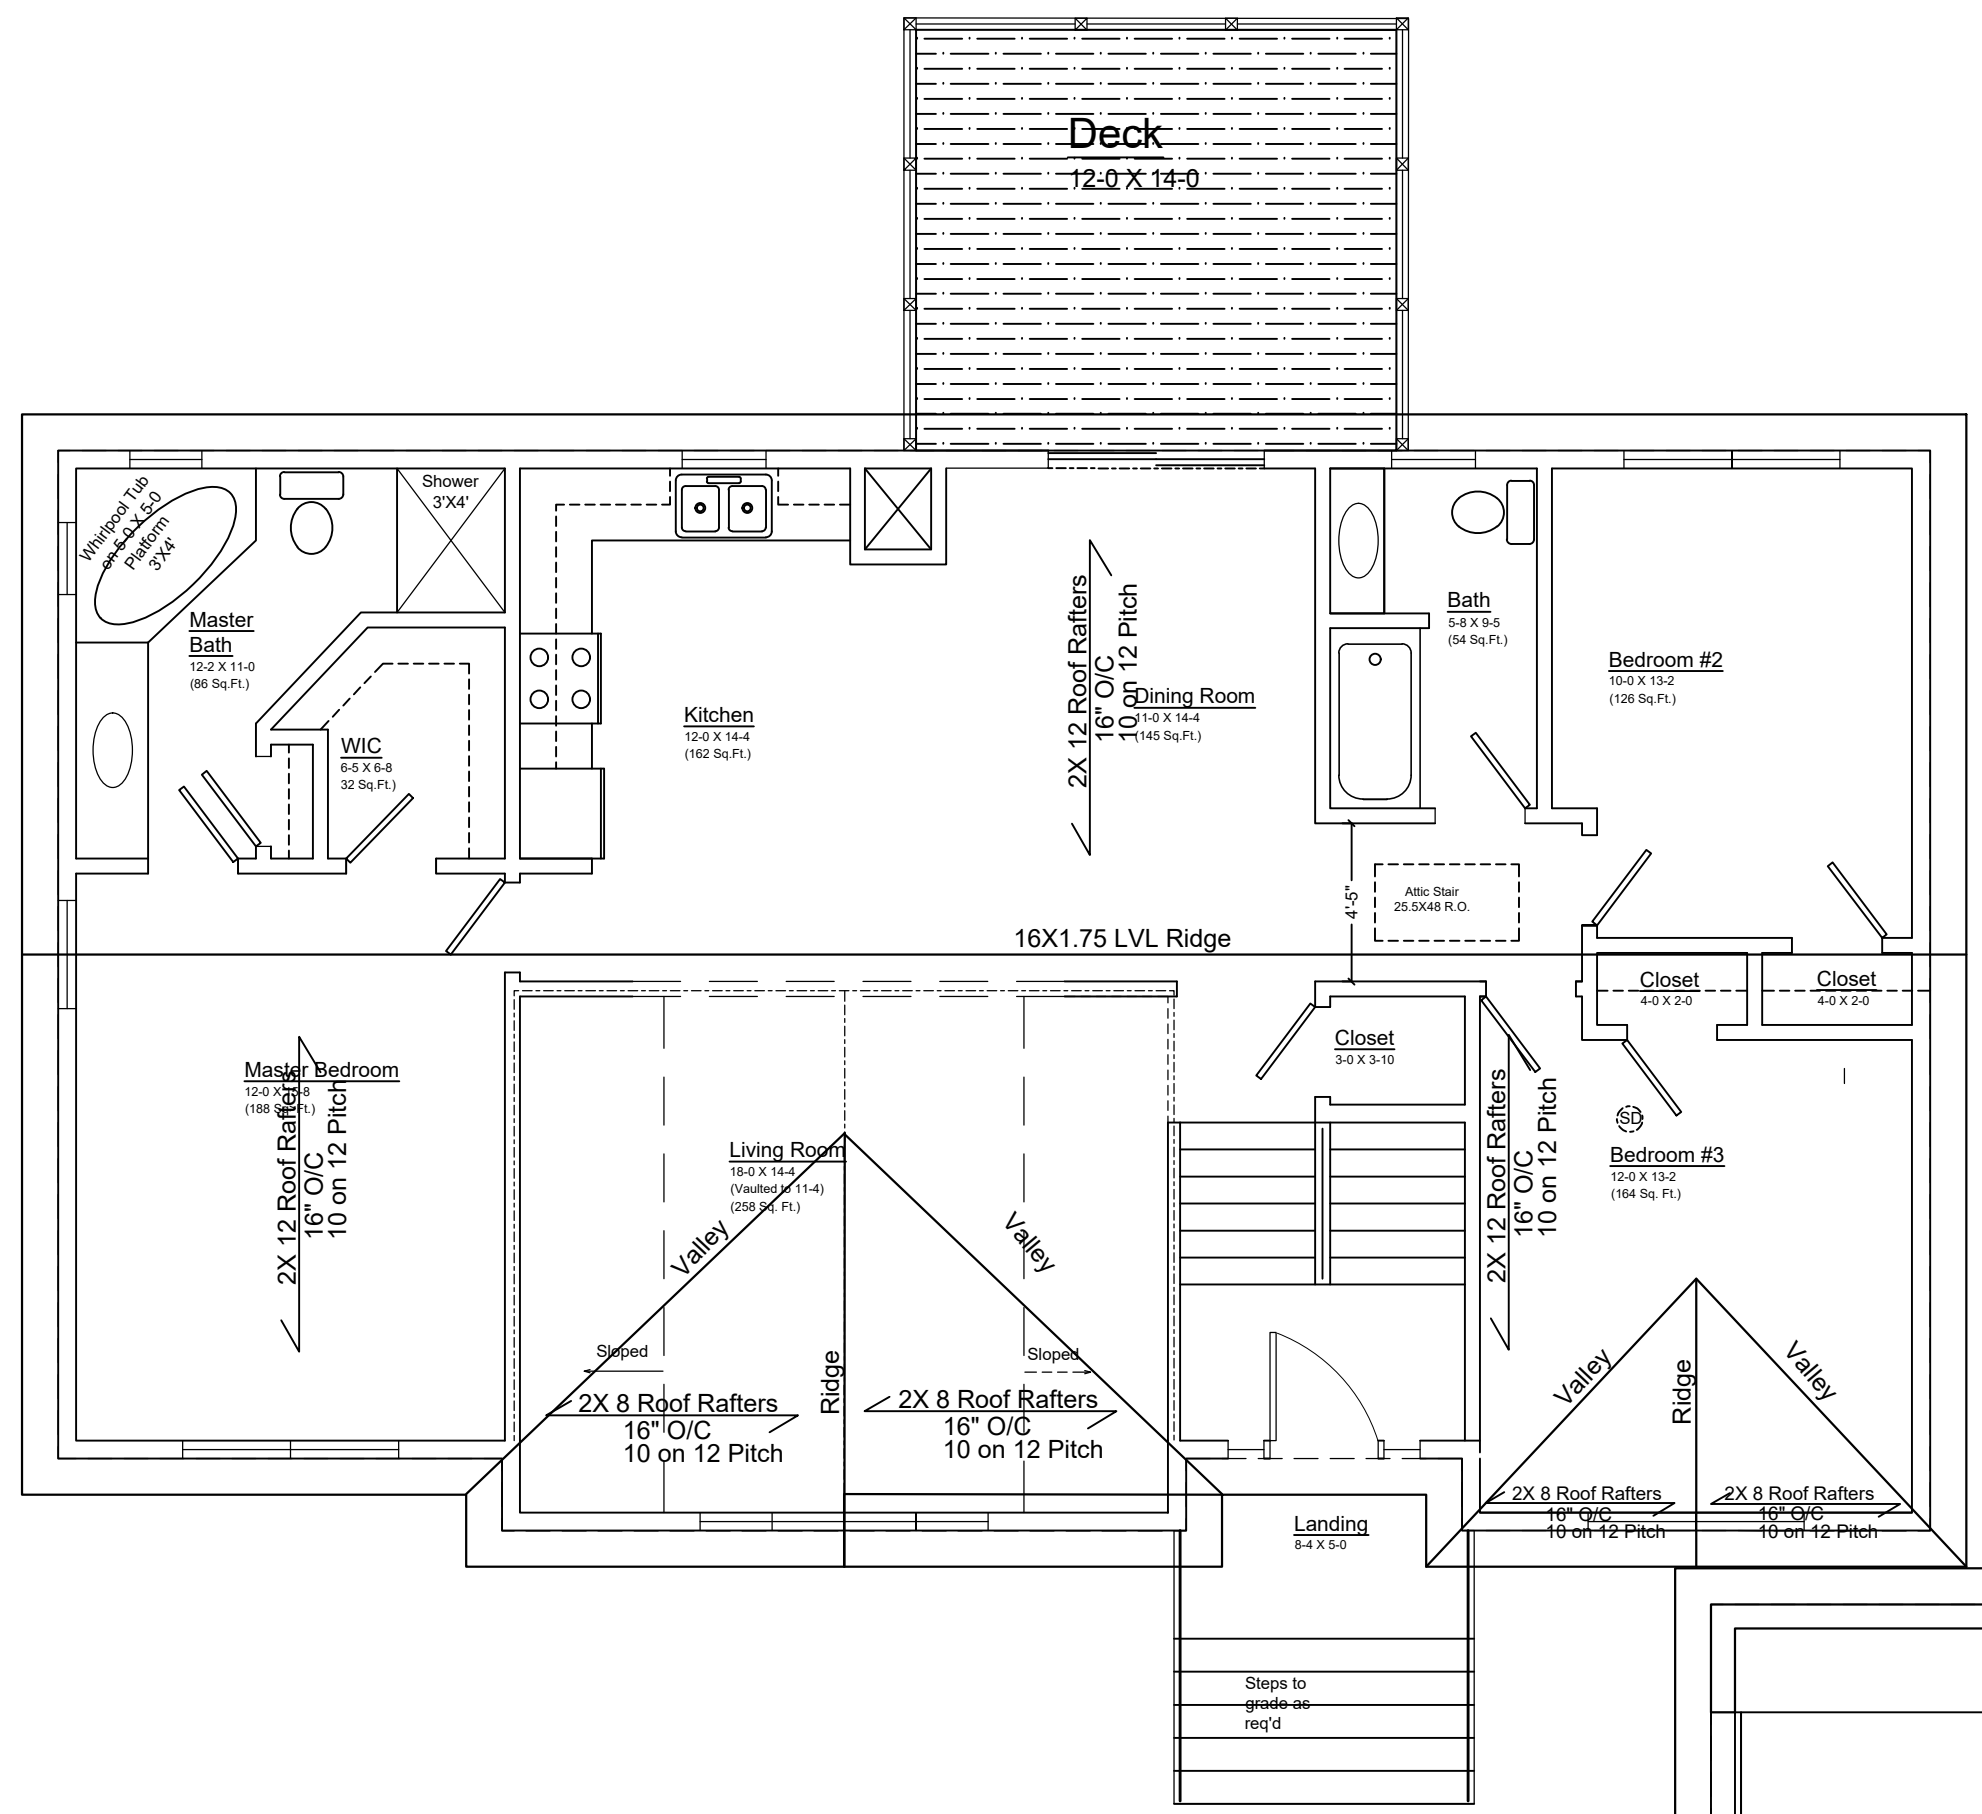

1 Upper Level Floor Plan
 SCALE: 3/8" = 1'-0"

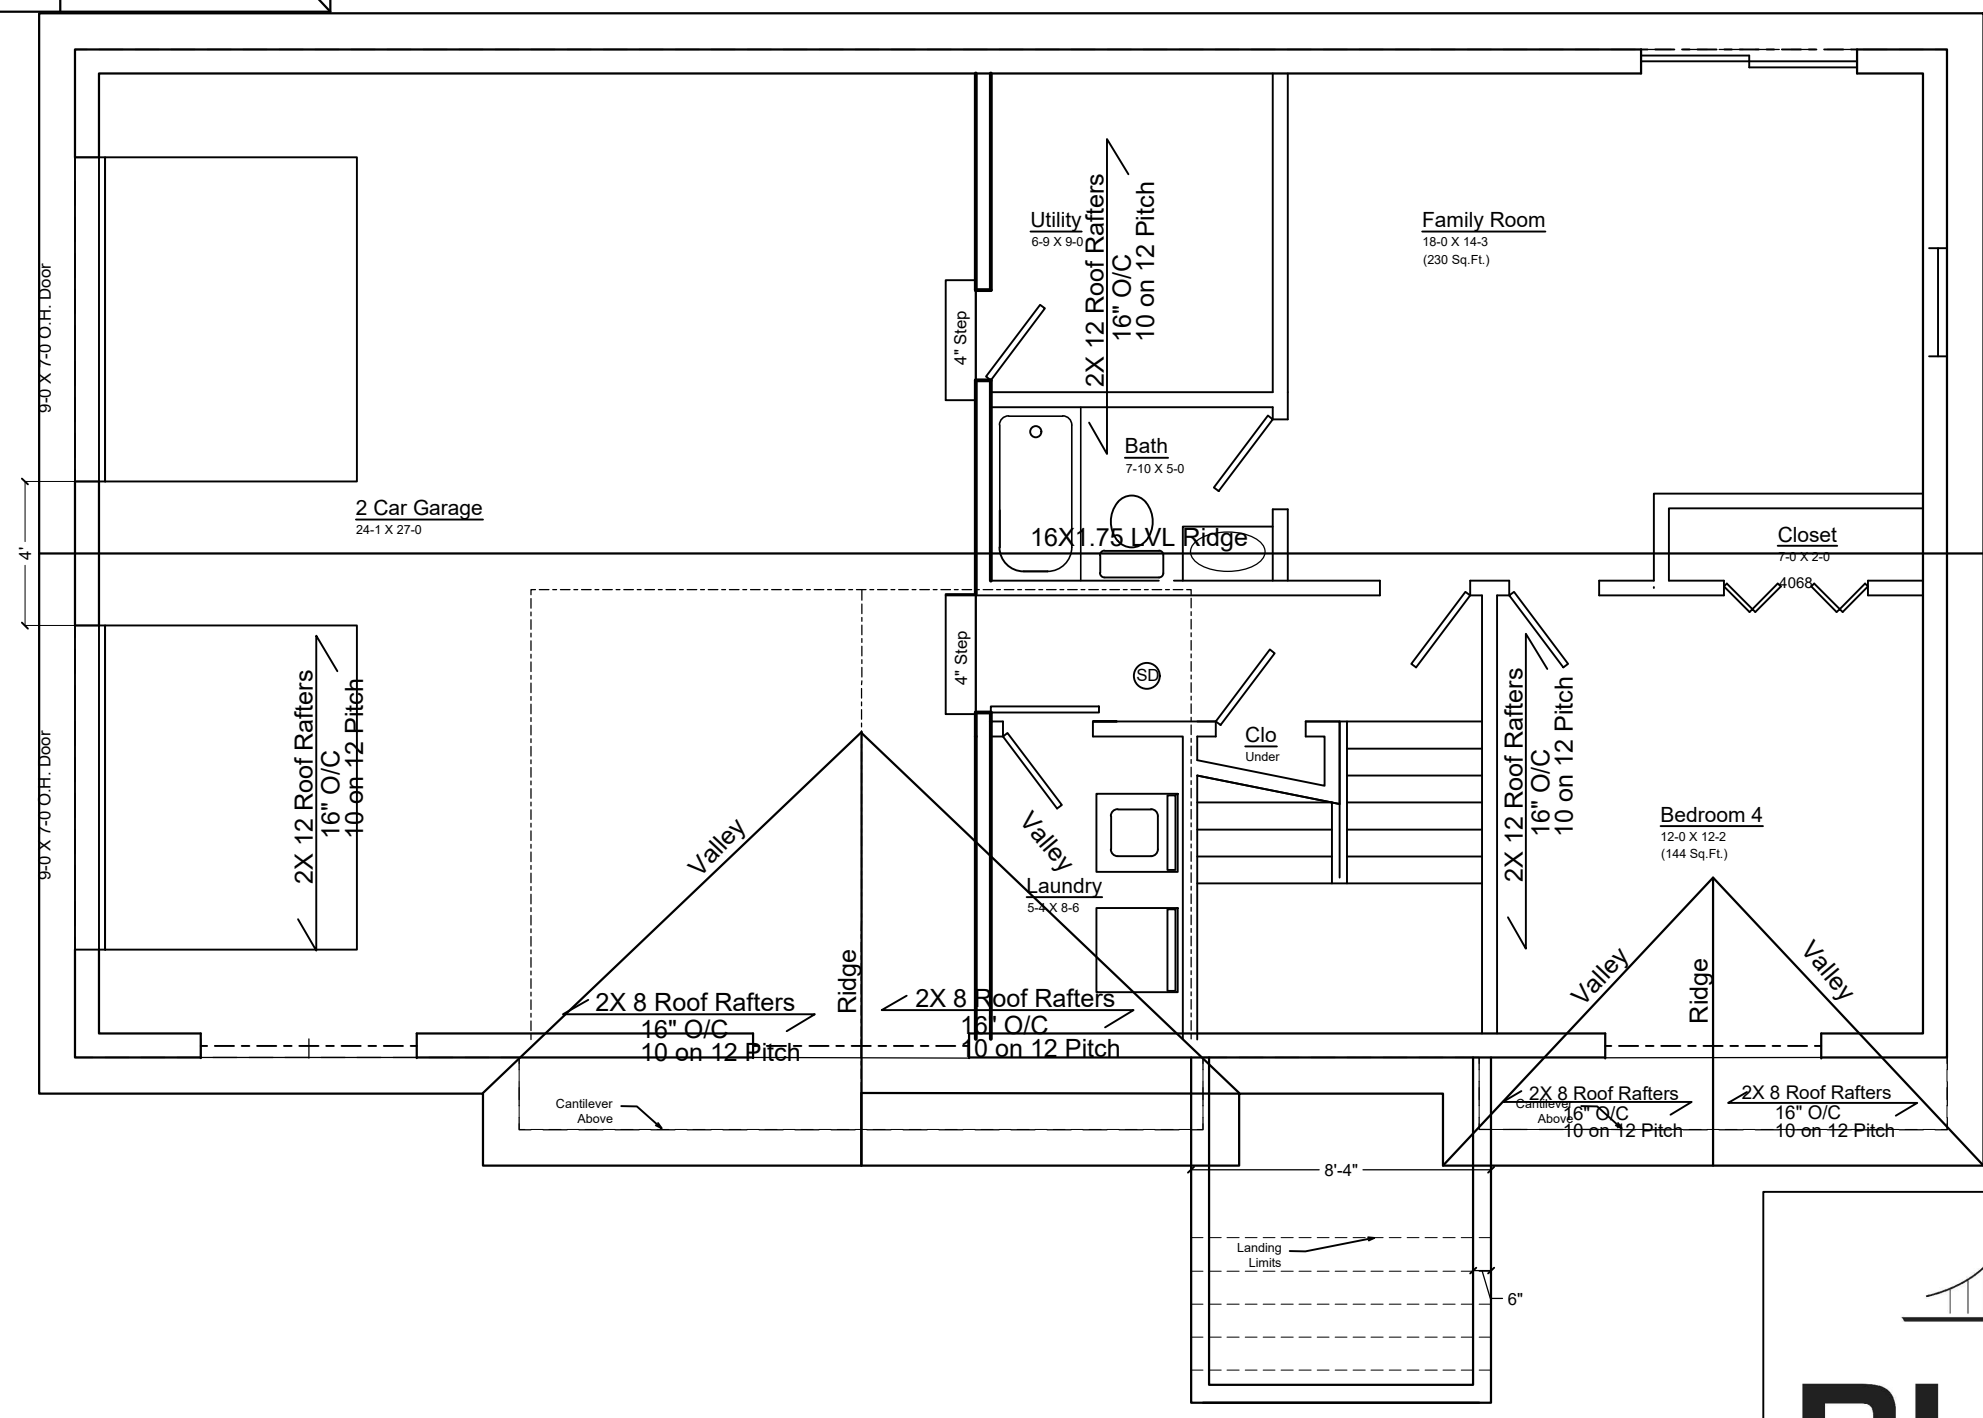

1 Lower Level Floor Plan
 SCALE: 3/8" = 1'-0"

BURNS
 ENGINEERING SERVICES, P.C.

Burns Engineering Services, P.C.
 58 Teller Avenue
 Beacon, NY 12508
 SBurns@BurnsEngineeringServices.Com
 (845) 546-3310
 Fax (845) 440-7343